

CHARLES NEWMAN
ENGINEERING
 LAMBERTVILLE, NJ
 PH 908-809-0320

THIS DRAWING, THE DESIGN IT ILLUSTRATES AND ALL CONCEPTS HEREIN ARE THE SOLE PROPERTY OF AMERICAN MANUFACTURED STRUCTURES AND SERVICES. NO PART OF THIS DRAWING OR DESIGN MAY BE REPRODUCED OR TRANSMITTED IN ANY FORM OR BY ANY MEANS, ELECTRONIC OR MECHANICAL, INCLUDING PHOTOCOPYING, RECORDING OR BY ANY INFORMATION STORAGE AND RETRIEVAL SYSTEM, WITHOUT WRITTEN PERMISSION FROM THE OWNER, AMERICAN MANUFACTURED STRUCTURES AND SERVICES


NO.	DATE	BY	REVISION

DATE: 02/07/12 DRAWN BY: CRN
 JOB NO.:

DRAWING TITLE:
FLOOR PLAN

PROJECT NAME:
MODULAR CABLE STATION

DRAWING NUMBER:
SK-1

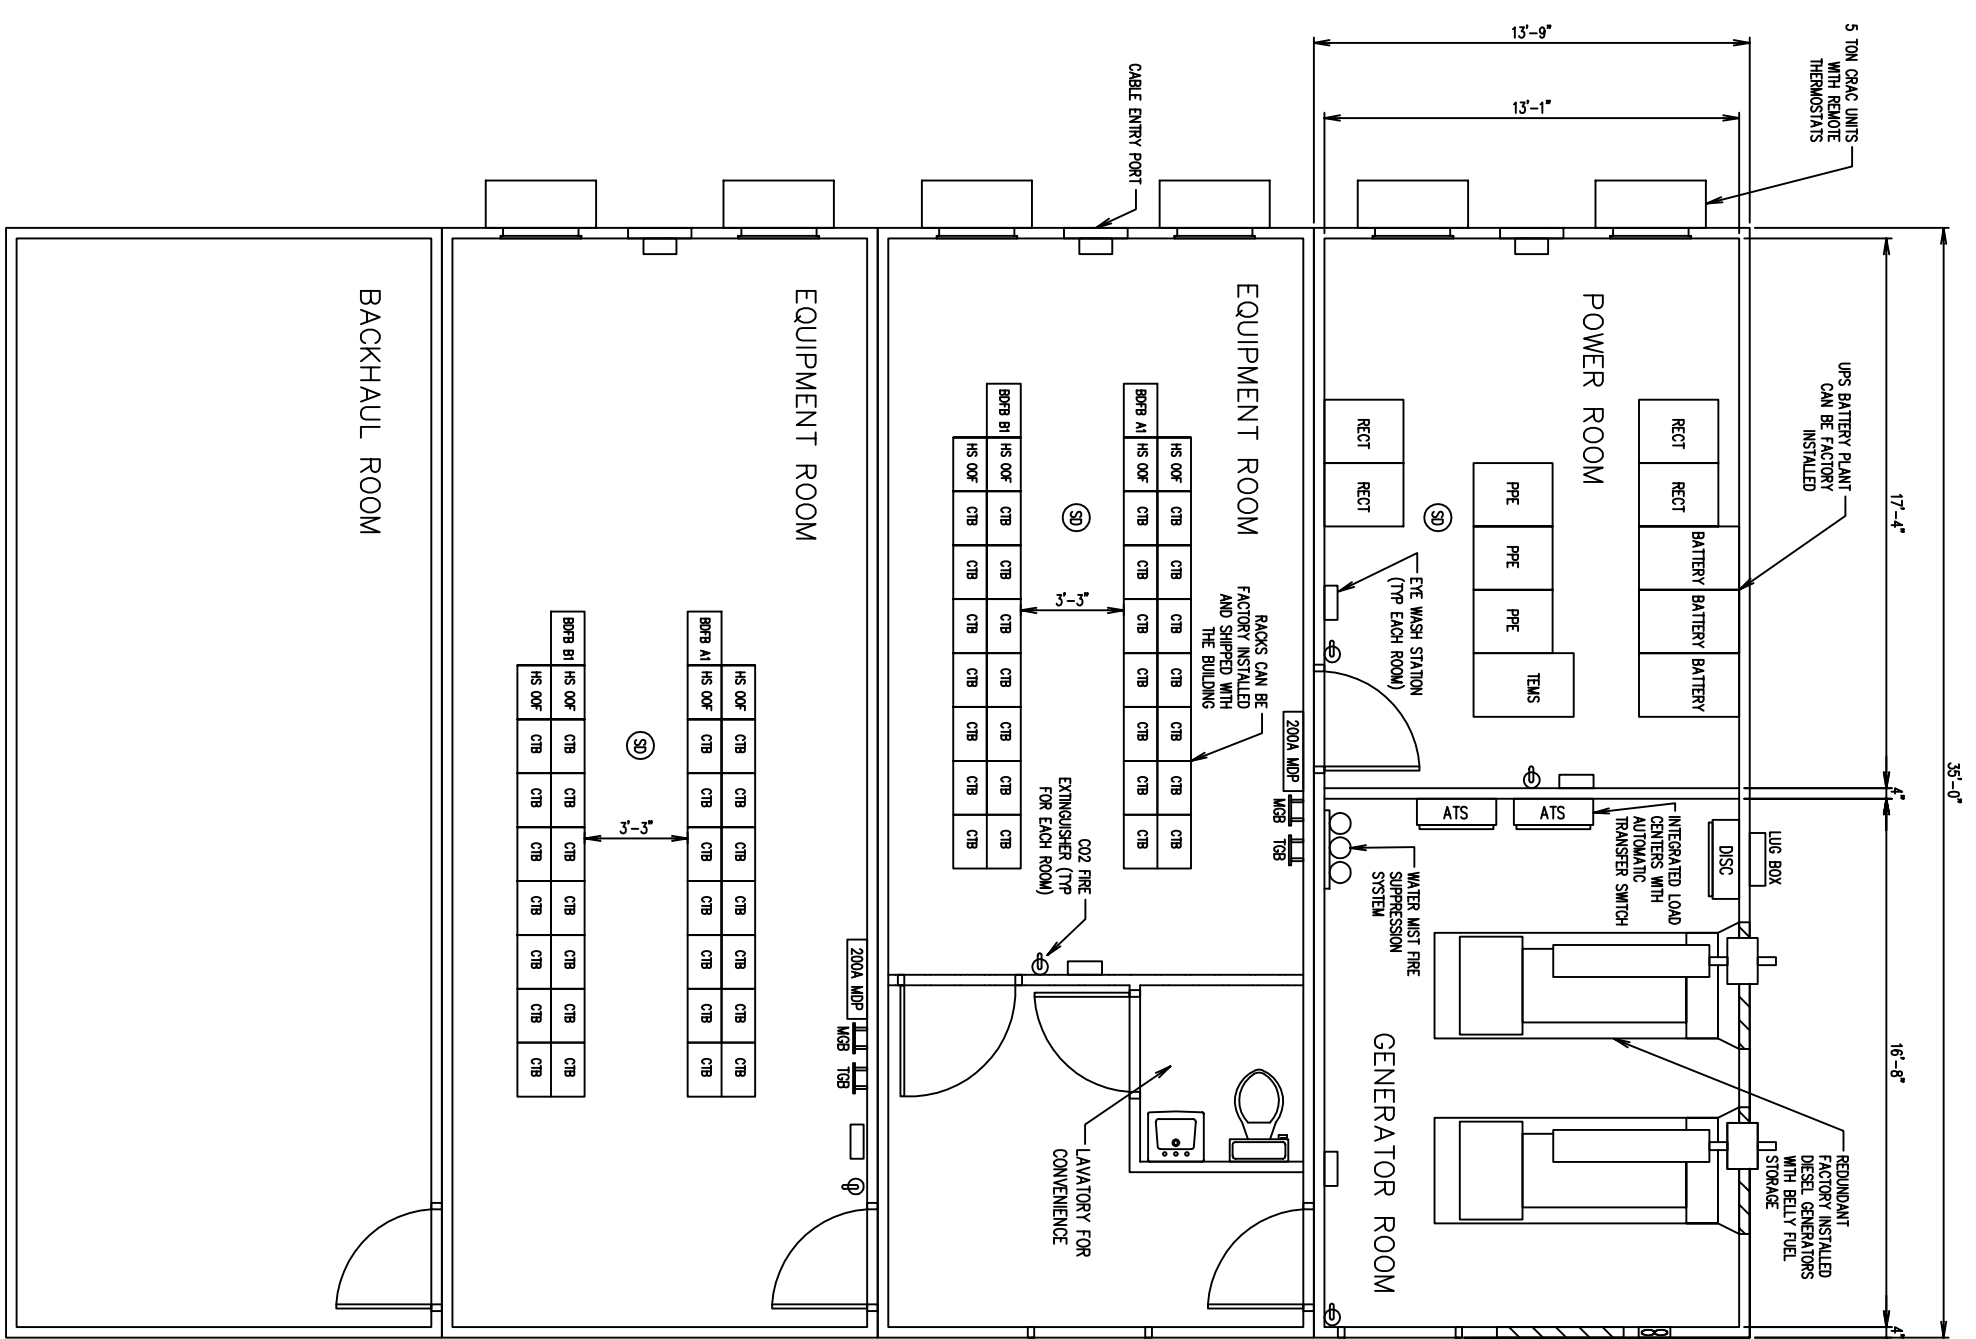

1 FLOOR PLAN
 SCALE: NONE